


06 ELECTRICAL PLAN
SCALE: 1/4"=1'-0"

ELECTRICAL LEGEND	
⊕	SWITCH
⊕ ³	3-WAY SWITCH
⊕ ^{110V}	110V RECEPTACLE
⊕ ^{GFCI}	GFCI
⊕ ^{WP}	GROUND FAULT CIRCUIT INTERRUPTER
⊕ ^{220V}	220V OUTLET
⊕ ^{INC}	CEILING MOUNTED INCANDESCENT OR FLUORESCENT LIGHT FIXTURE
⊕ ^{WALL}	WALL MOUNTED INCANDESCENT LIGHT FIXTURE
⊕ ^{DISC}	DISCONNECT
⊕ ^{JUN}	JUNCTION BOX
⊕ ^{THER}	THERMOSTAT
⊕ ^{SMOKE}	CEILING MOUNTED SMOKE DETECTOR
⊕ ^{FAN}	EXHAUST FAN / LIGHT COMBO

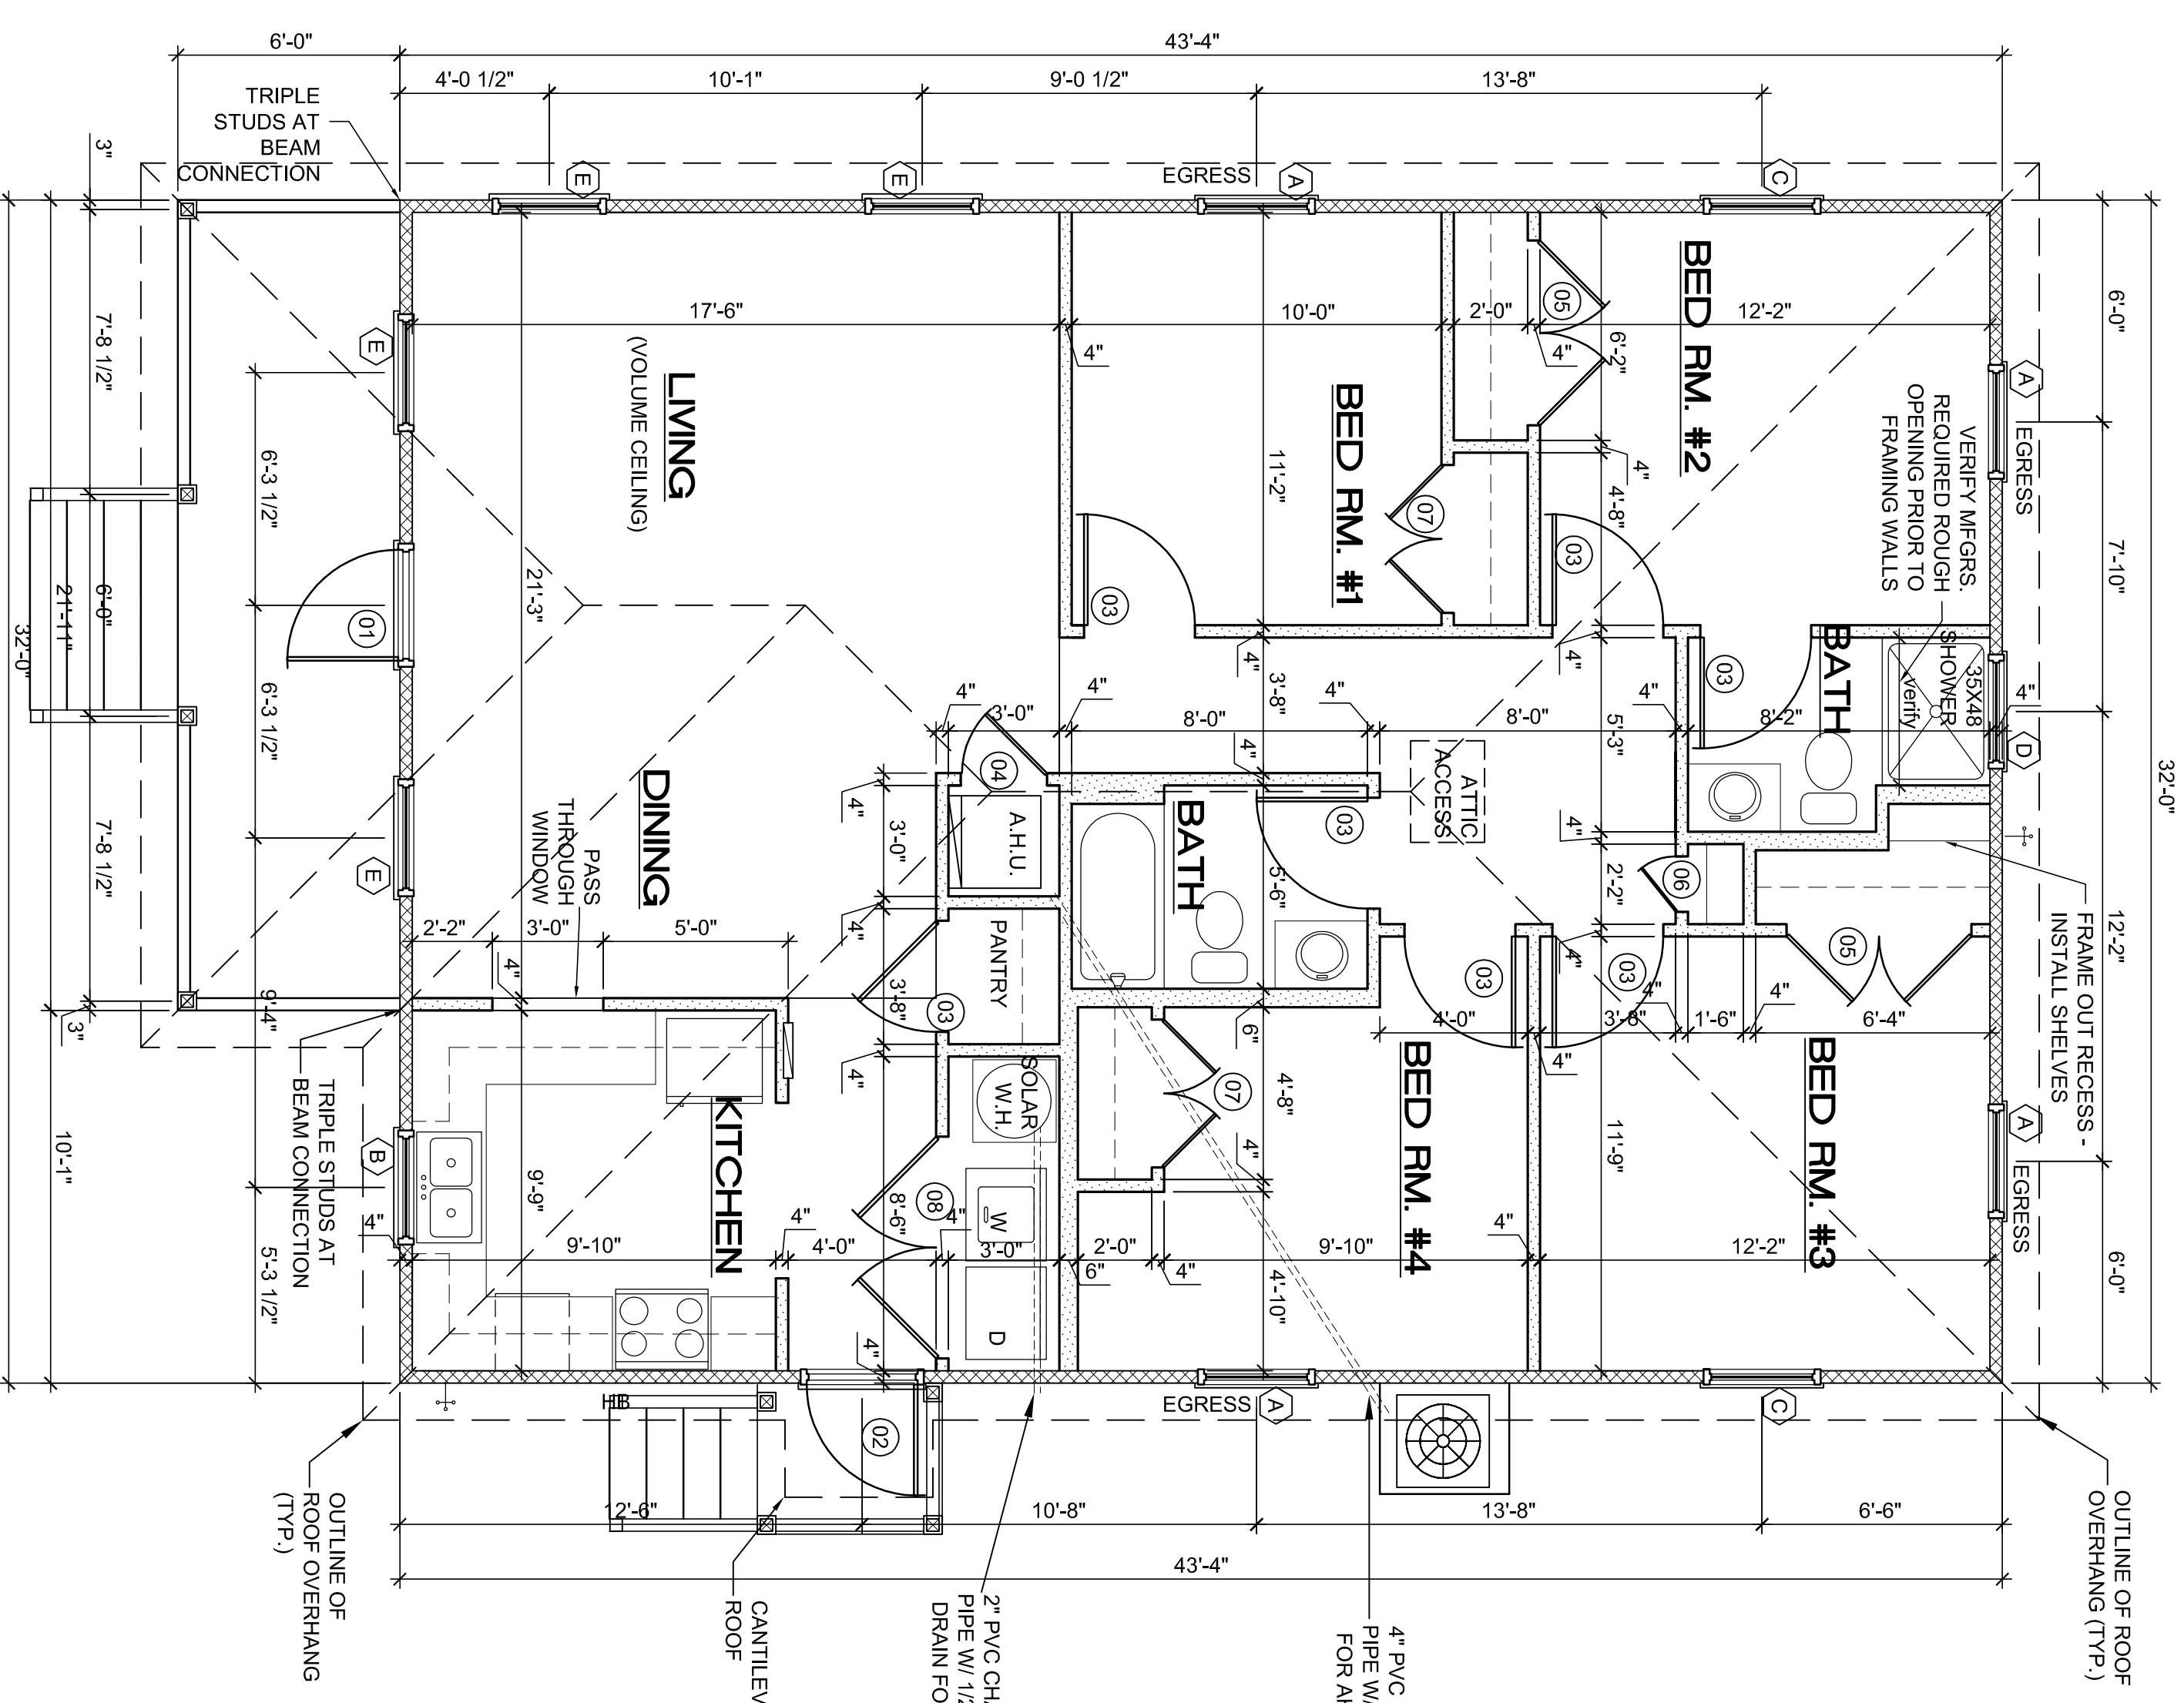

06 FLOOR PLAN
SCALE: 1/4"=1'-0"

AREA INFORMATION	
LIVING AREA U/A (4 BD/2 BA)	1,387 sq.ft.
1530 sq.ft. (incl. Lg. Area)	132 sq.ft.
PORCH / ENTRY	
TOTAL	1,519 sq.ft.

DOOR SCHEDULE	
(01) 3'-0" x 6'-6"	Exl. Metal Insulated
(02) 3'-0" x 6'-6"	Exl. Metal Insulated w/ glass
(03) 3'-0" x 6'-6"	Int. 6 Panel
(04) 2'-4" x 6'-6"	Int. 6 Panel
(05) 3'-0" x 6'-6"	Int. 6 Panel
(06) 3'-0" x 6'-6"	Int. 6 Panel
(07) 3'-0" x 6'-6"	Int. 6 Panel
(100) 3'-0" x 6'-6"	Int. 6 Panel

WINDOW SCHEDULE	
A) SH25	RO. 36 1/2" X 62 1/2"
B) SH23	RO. 36 1/2" X 37 7/8"
C) HR22	RO. 36 1/4" X 25 1/4"
D) SH2	RO. 36 1/2" X 25 1/4"
E) SH24	RO. 36 1/2" X 50 1/8"
F) SH34	NOT USED

NOTES
2-10x6 STAMP GRILLS ABOVE EACH BEDROOM DOOR FOR VENTILATION WHERE REQUIRED BY CODE. IN ADDITION, UNDERCUT EACH DOOR BY ONE INCH.
DIRECT SOLAR WATER HEATING SYSTEM BY OTHERS. SMALL PHOTO-VOLTAIC PANEL AND DC PUMP.

